


© 2001 Jagoe Homes, Inc. Unauthorized use of this plan is in violation of the U.S. Copyright Act, Title 17 of the U.S. Code. Reported square footage is approximate and based upon Architectural Design. Area and actual dimensions may vary according to construction methods. Dimensions used on floor plans are framing dimensions. Municipality requirements regarding size of foundation block may affect framing dimensions shown on plans. Brochures as shown by artist's renditions may not show all standards and options. Specifications may change without notice. Variations may occur by neighborhood, lot location, and home series. Not all plan brochures may be placed on every lot. Location of residence on lot shall be determined by Jagoe Homes Inc.



GENERAL NOTES:
 * SET ANCHOR BOLTS 3 1/2" ABOVE BLOCK

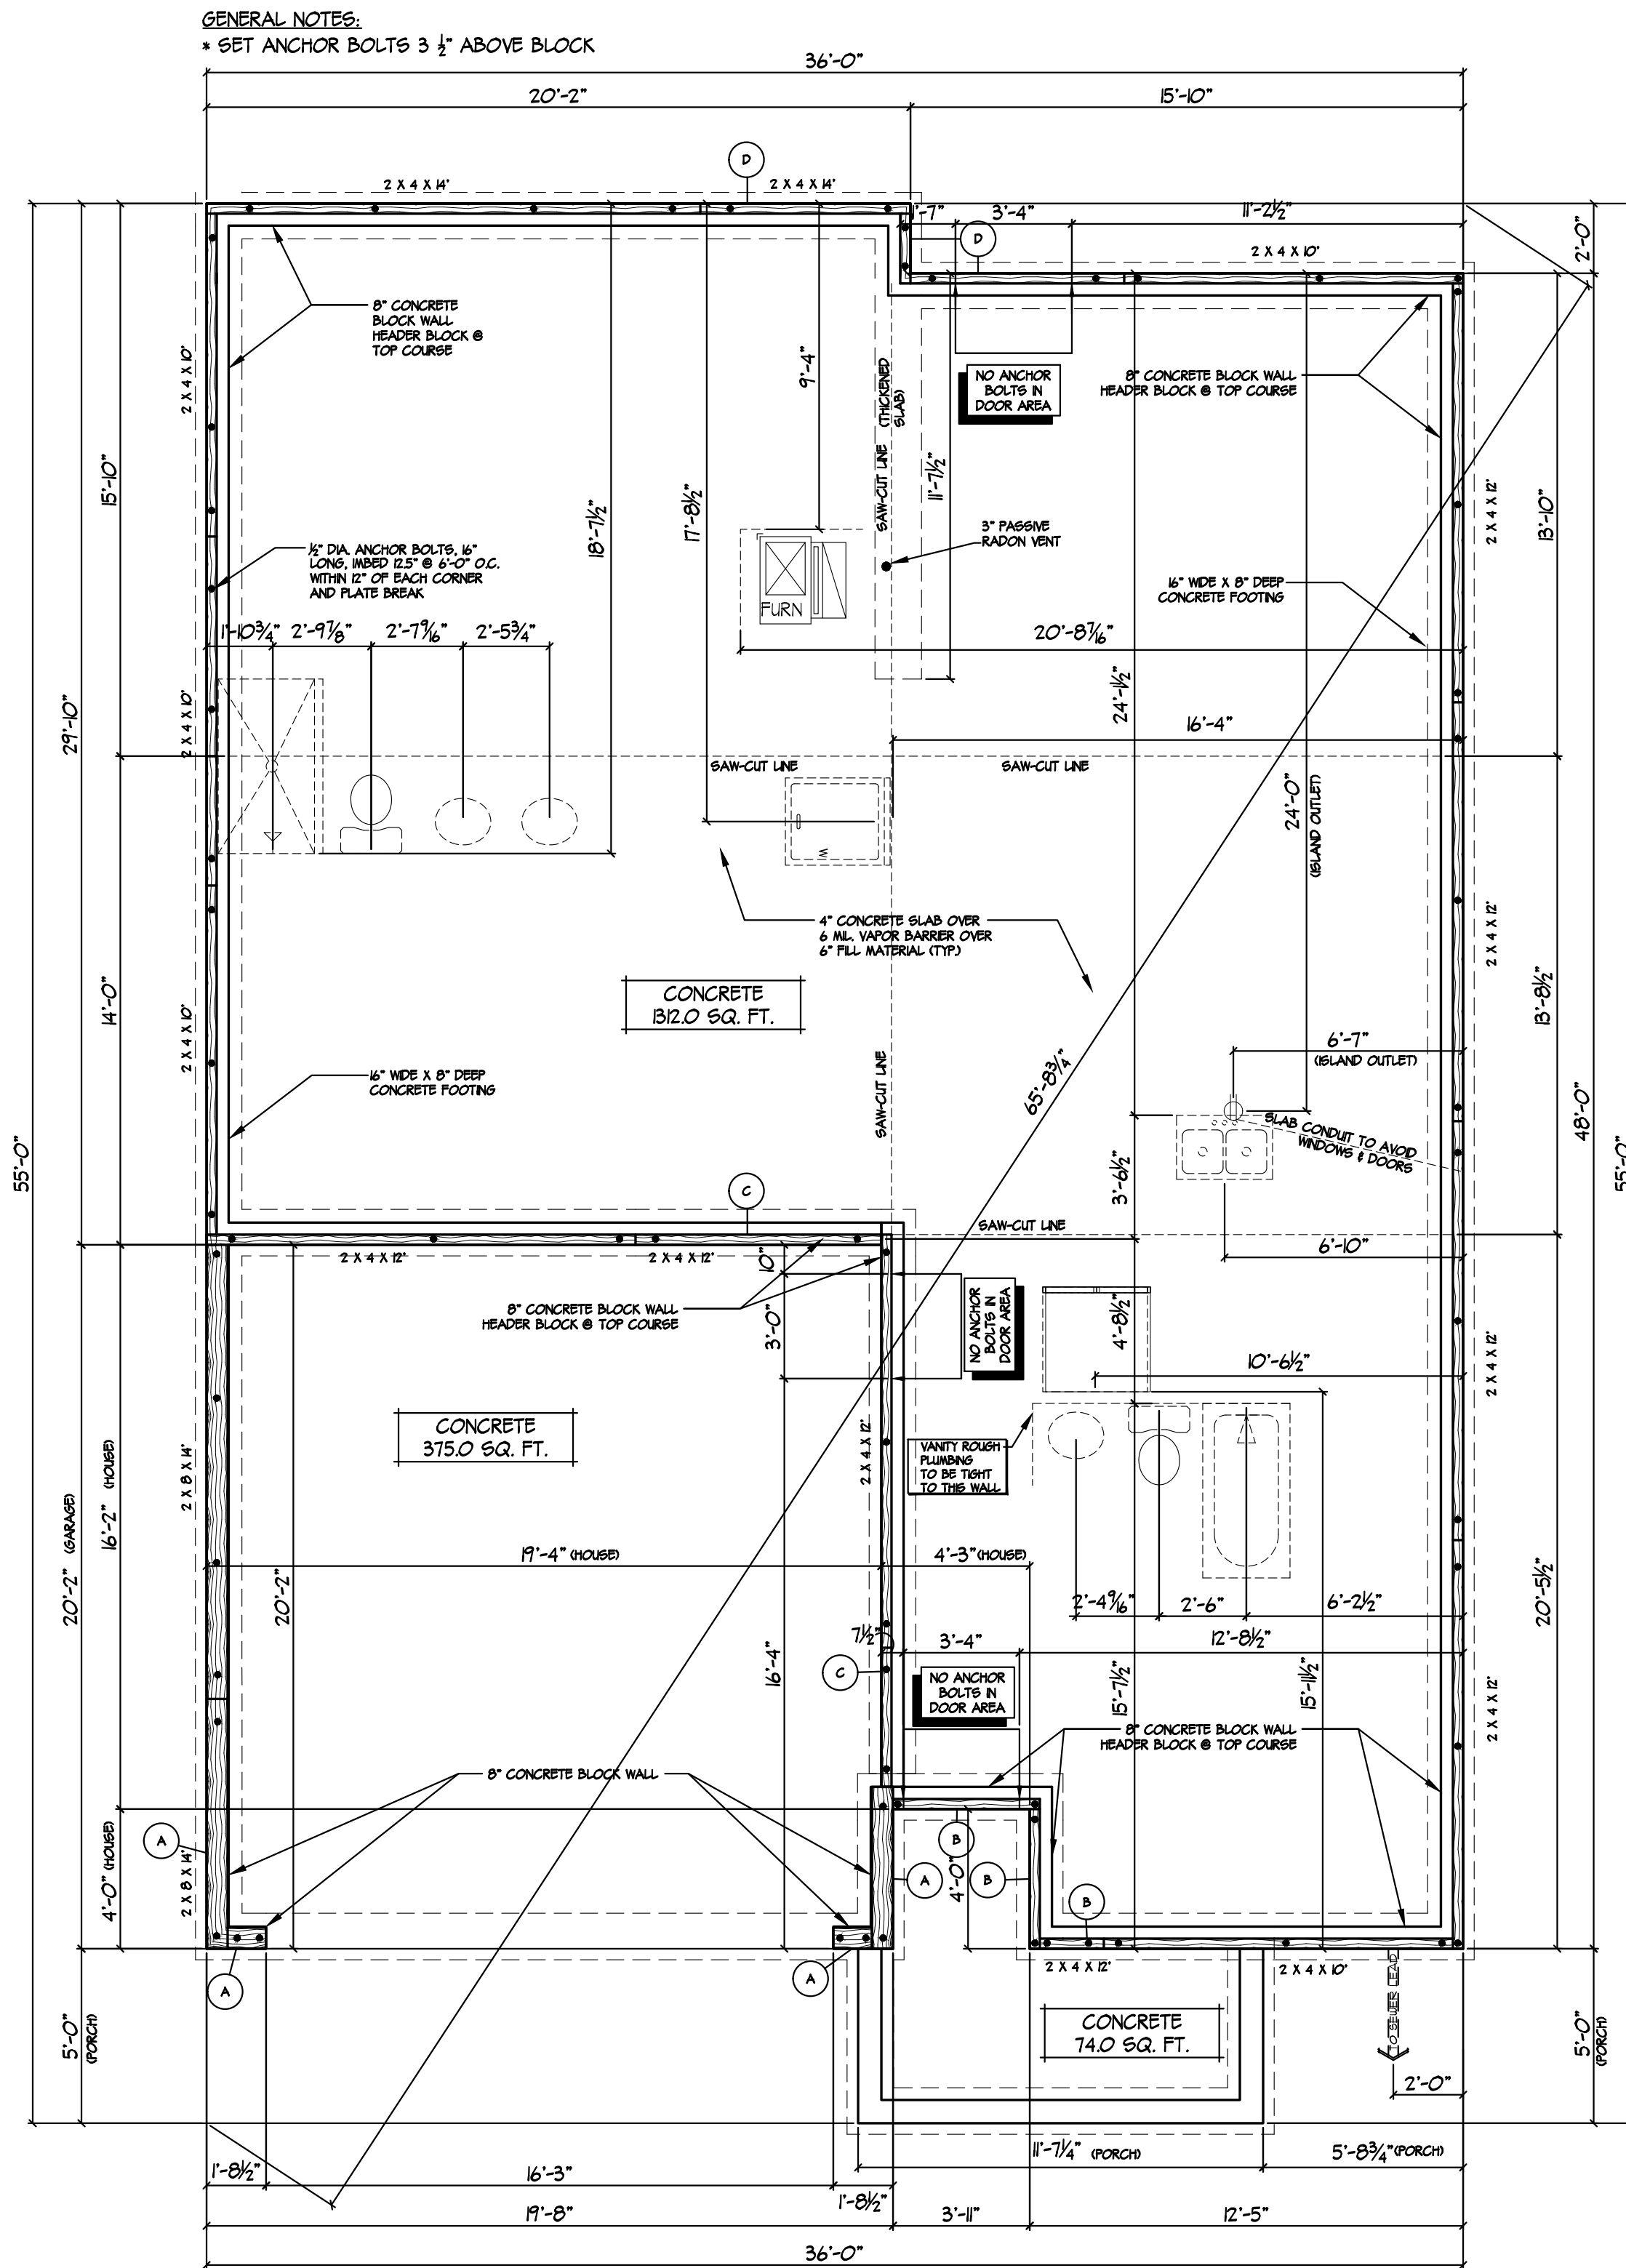


3624 WATHENS CROSSING
 OWENSBORO, KENTUCKY 42301
 (270) 684-0639

DATE: September 16, 2022	
LAST SAVED BY: Fredd.Lucille	
LAST SAVED: Thu, 15 Sep 2022 - 3:08pm	
CREATED: Wed, 29 Aug 2012 - 9:56am	
FILE NAME: 29 WL MKT PLAN 091422.dwg	
TIME PLOTTED: Fri, 16 Sep 2022 - 8:46am	
REVISION:	
PDR#A.B.	DATE:08/15/13
PDR#298	DATE:10/14/13
PDR#730	DATE:7/11/18
PDR#832	DATE:01/07/19
PDR#000	DATE:00/00/00


JAGOE MARKET HOME
 9845 MONTE WAY
 NEWBURGH, IN 47630
 LOT 29 WILLIAMS LANDING
 LEONARDO - C
 FOUNDATION PLAN C.ELEV.

Sheet Number
C.1.1.1


© 2001 Jagoe Homes, Inc. Unauthorized use of this plan is in violation of the U.S. Copyright Act, Title 17 of the U.S. Code. Reported square footage is approximate and based upon Architectural Design. Area and actual dimensions may vary according to construction methods. Dimensions used on floor plans are framing dimensions. Municipality requirements regarding size of foundation block may affect framing dimensions shown on plans. Brochures as shown by artist's renditions may not show all standards and options. Specifications may change without notice. Variations may occur by neighborhood, lot location, and home series. Not all plan brochures may be placed on every lot. Location of residence on lot shall be determined by Jagoe Homes Inc.

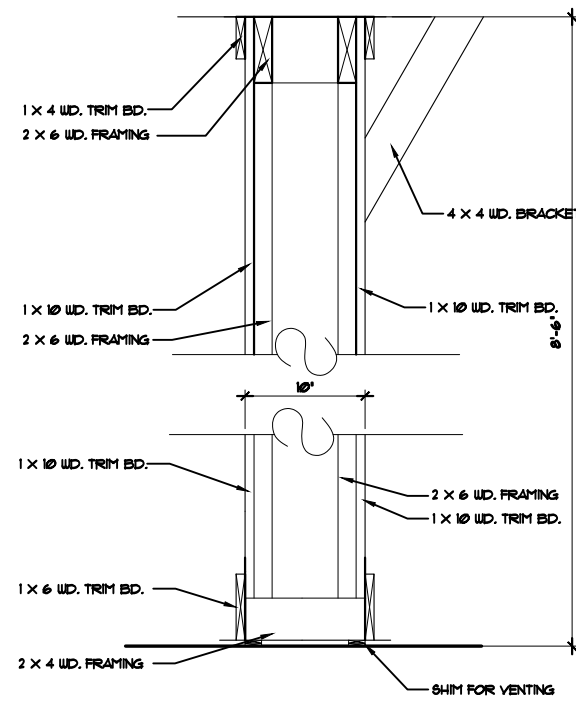


**10" X 10" WD.
BUILT-UP COLUMN**
SCALE: 3/4" = 1'-0"

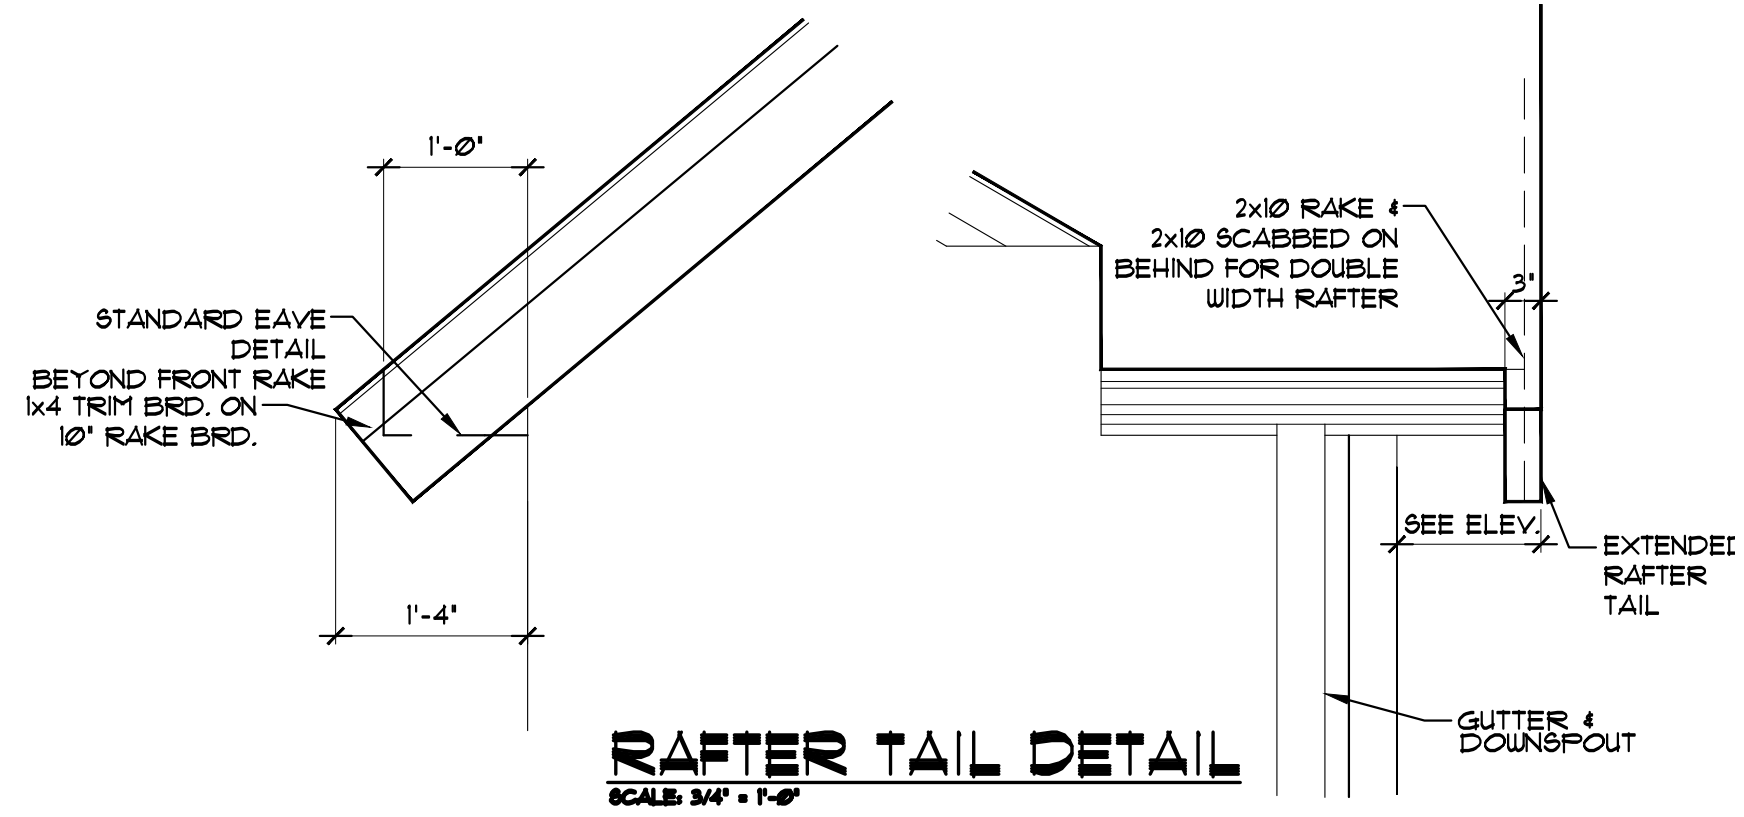


RAFTER TAIL DETAIL
SCALE: 3/4" = 1'-0"

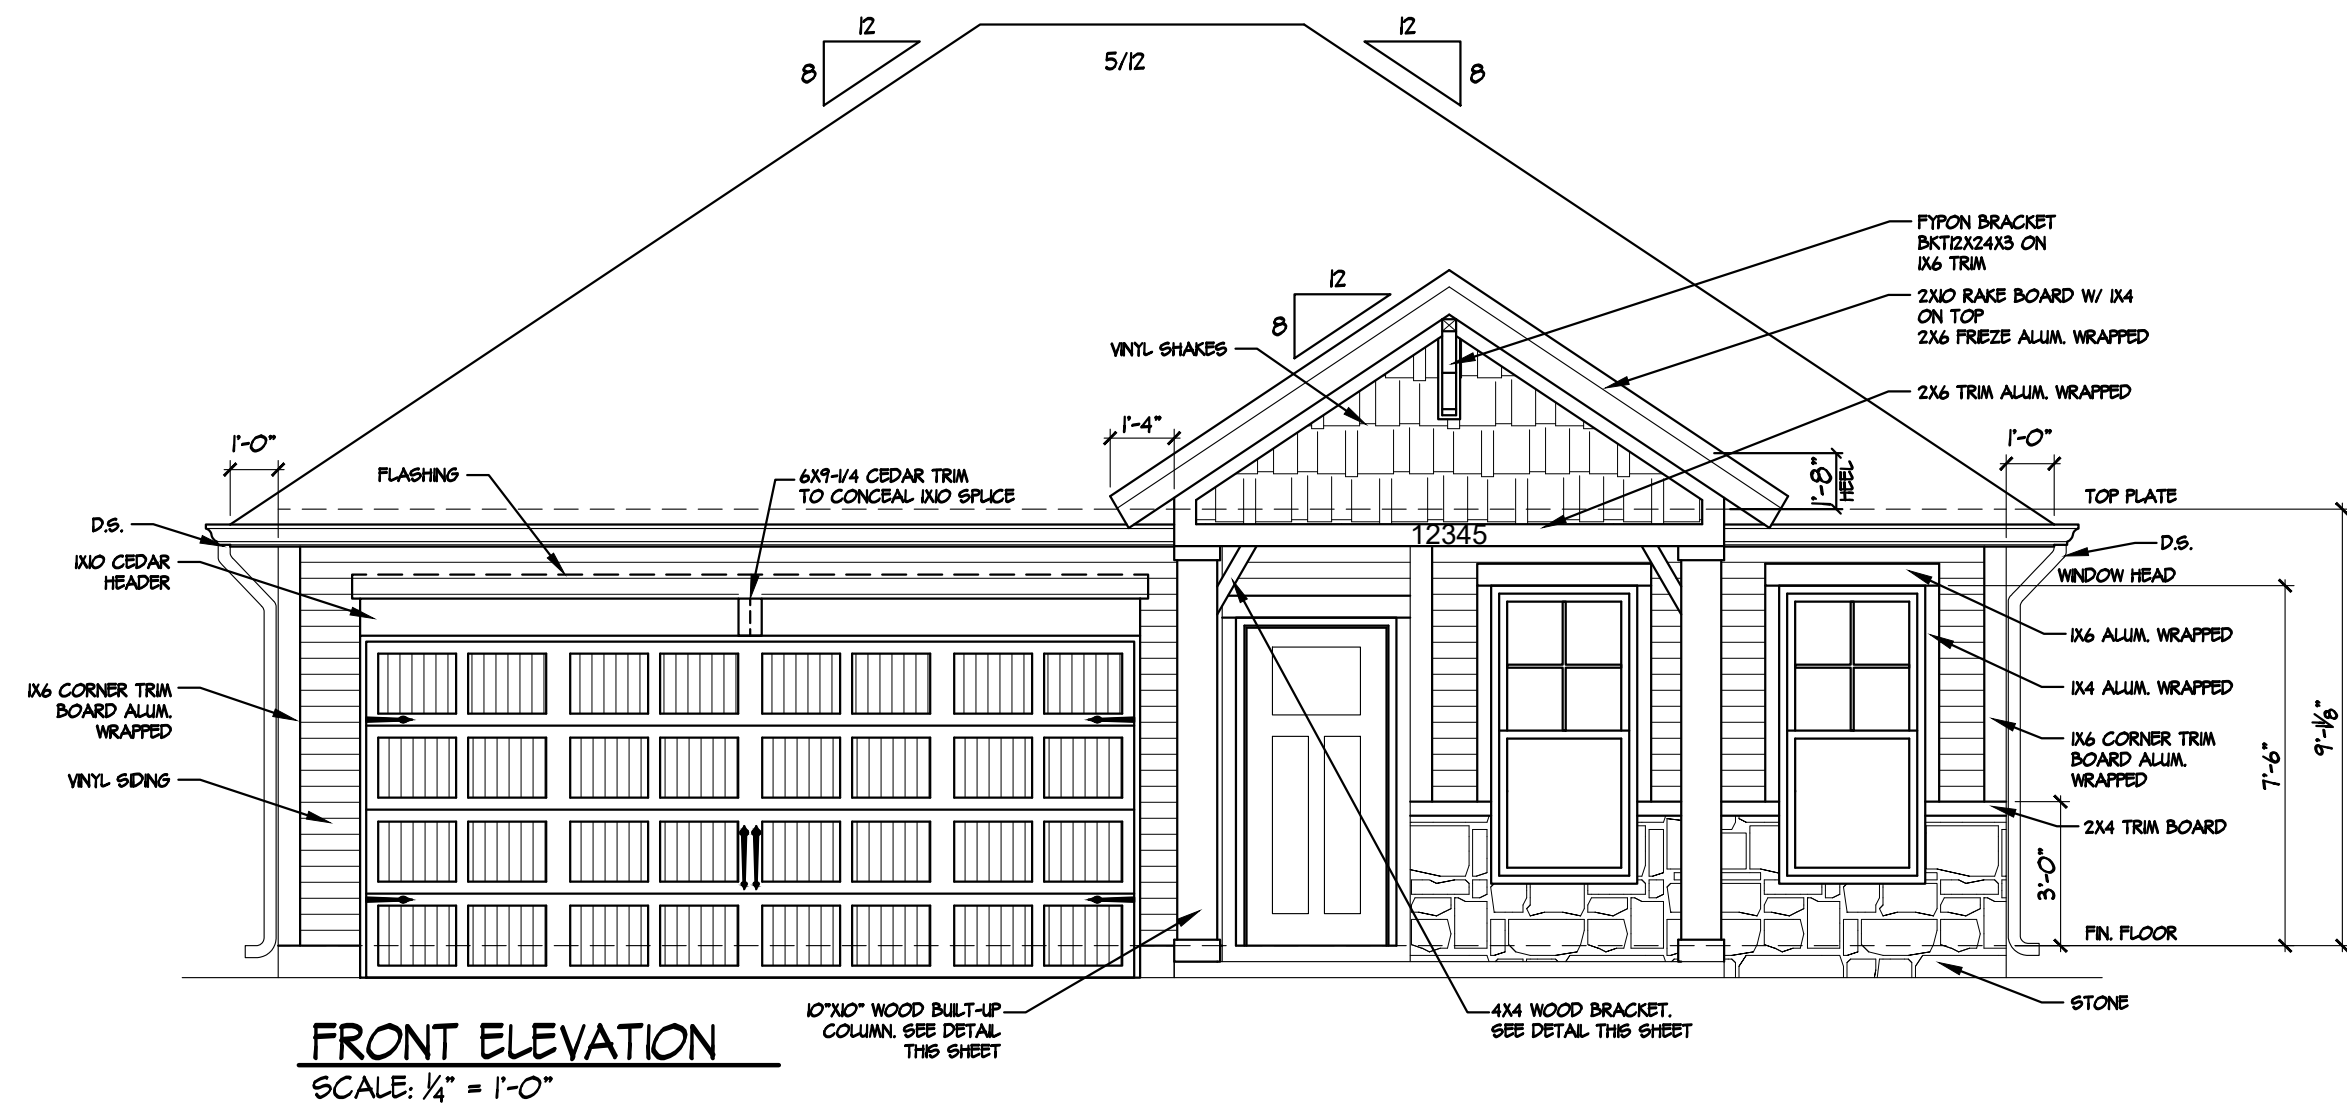

FRONT ELEVATION
SCALE: 1/4" = 1'-0"

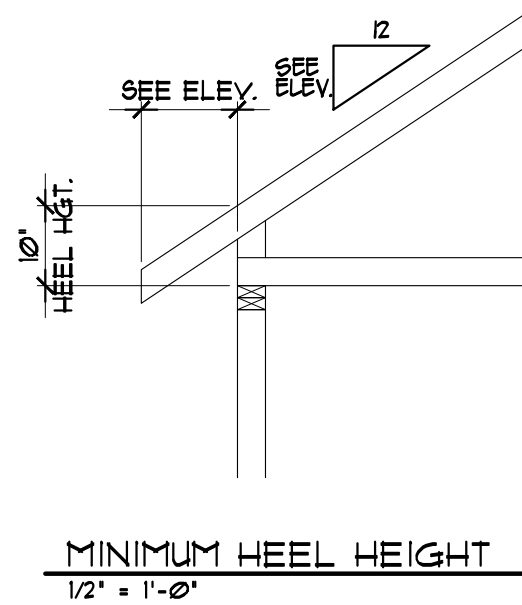

MINIMUM HEEL HEIGHT
1/2" = 1'-0"

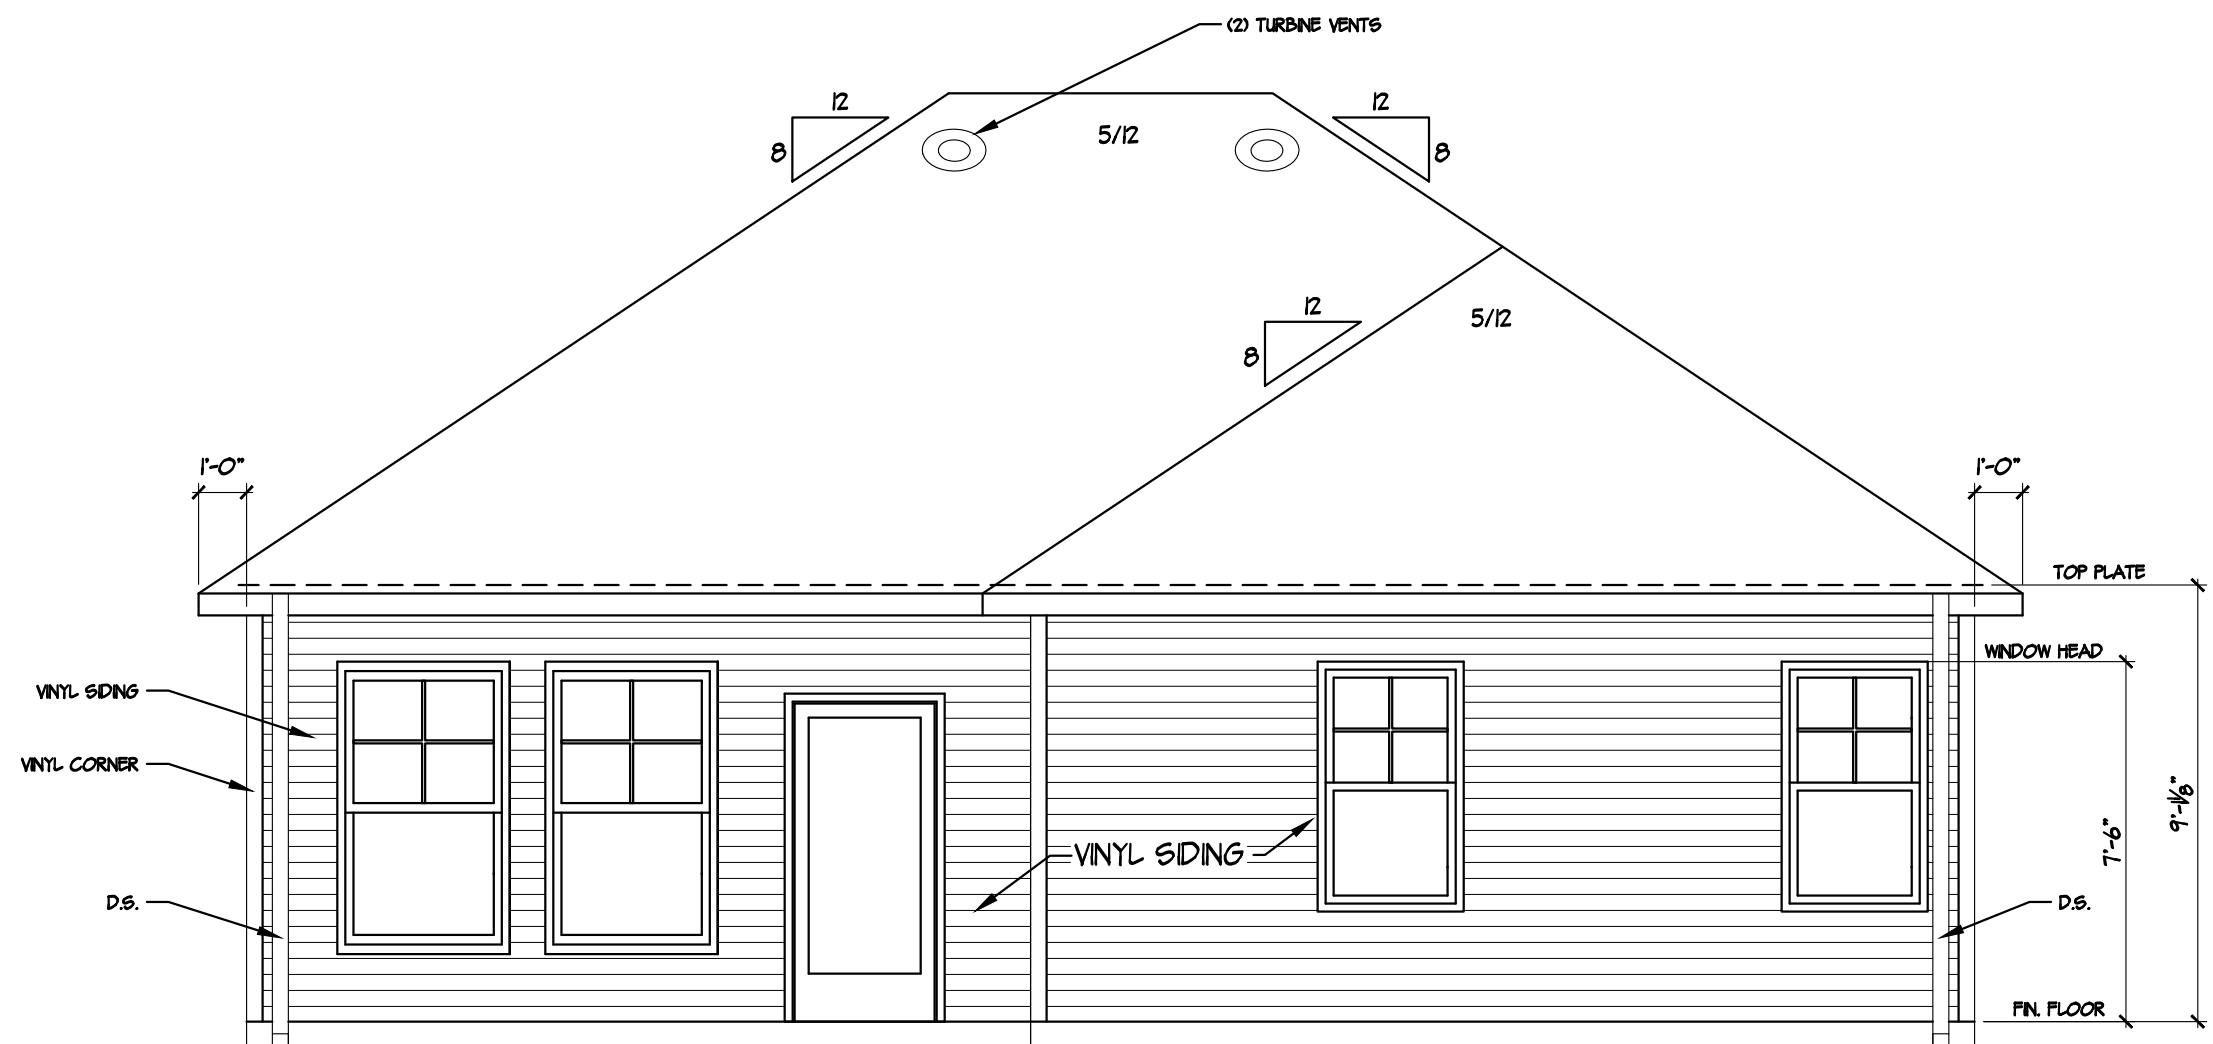

REAR ELEVATION
SCALE: 1/8" = 1'-0"

JAGOE HOMES



3624 WATHENS CROSSING
OWENSBORO, KENTUCKY 42301
(270) 684-0639

DATE:	September 16, 2022
LAST SAVED BY:	Fredd.Lucille
LAST SAVED:	Thu, 15 Sep 2022 - 3:08pm
CREATED:	Wed, 29 Aug 2012 - 9:56am
FILE NAME:	29 WL MKT PLAN 091422.dwg
TIME PLOTTED:	Fri, 16 Sep 2022 - 8:47am
REVISION:	
PDR#A.B.	DATE:08/15/13
PDR#298	DATE:10/14/13
PDR#730	DATE:7/11/18
PDR#832	DATE:01/07/19
PDR#000	DATE:00/00/00

JAGOE MARKET HOME
9845 MONTE WAY
NEWBURGH, IN 47630
LOT 29 WILLIAMS LANDING
LEONARDO - C
RIGHT & SIDE ELEVATIONS C

Sheet Number
C.5.1.1

© 2001 Jagoe Homes, Inc. Unauthorised use of this plan is in violation of the U.S. Copyright Act, Title 17 of the U.S. Code. Reported square footage is approximate and based upon Architectural Design. Area and actual dimensions may vary according to construction methods. Dimensions used on floor plans are framing dimensions. Municipality requirements regarding size of foundation block may affect framing dimensions shown on plans. Brochures as shown by artist's renditions may not show all standards and options. Specifications may change without notice. Variations may occur by neighborhood, lot location, and home series. Not all plan brochures may be placed on every lot. Location of residence on lot shall be determined by Jagoe Homes Inc.

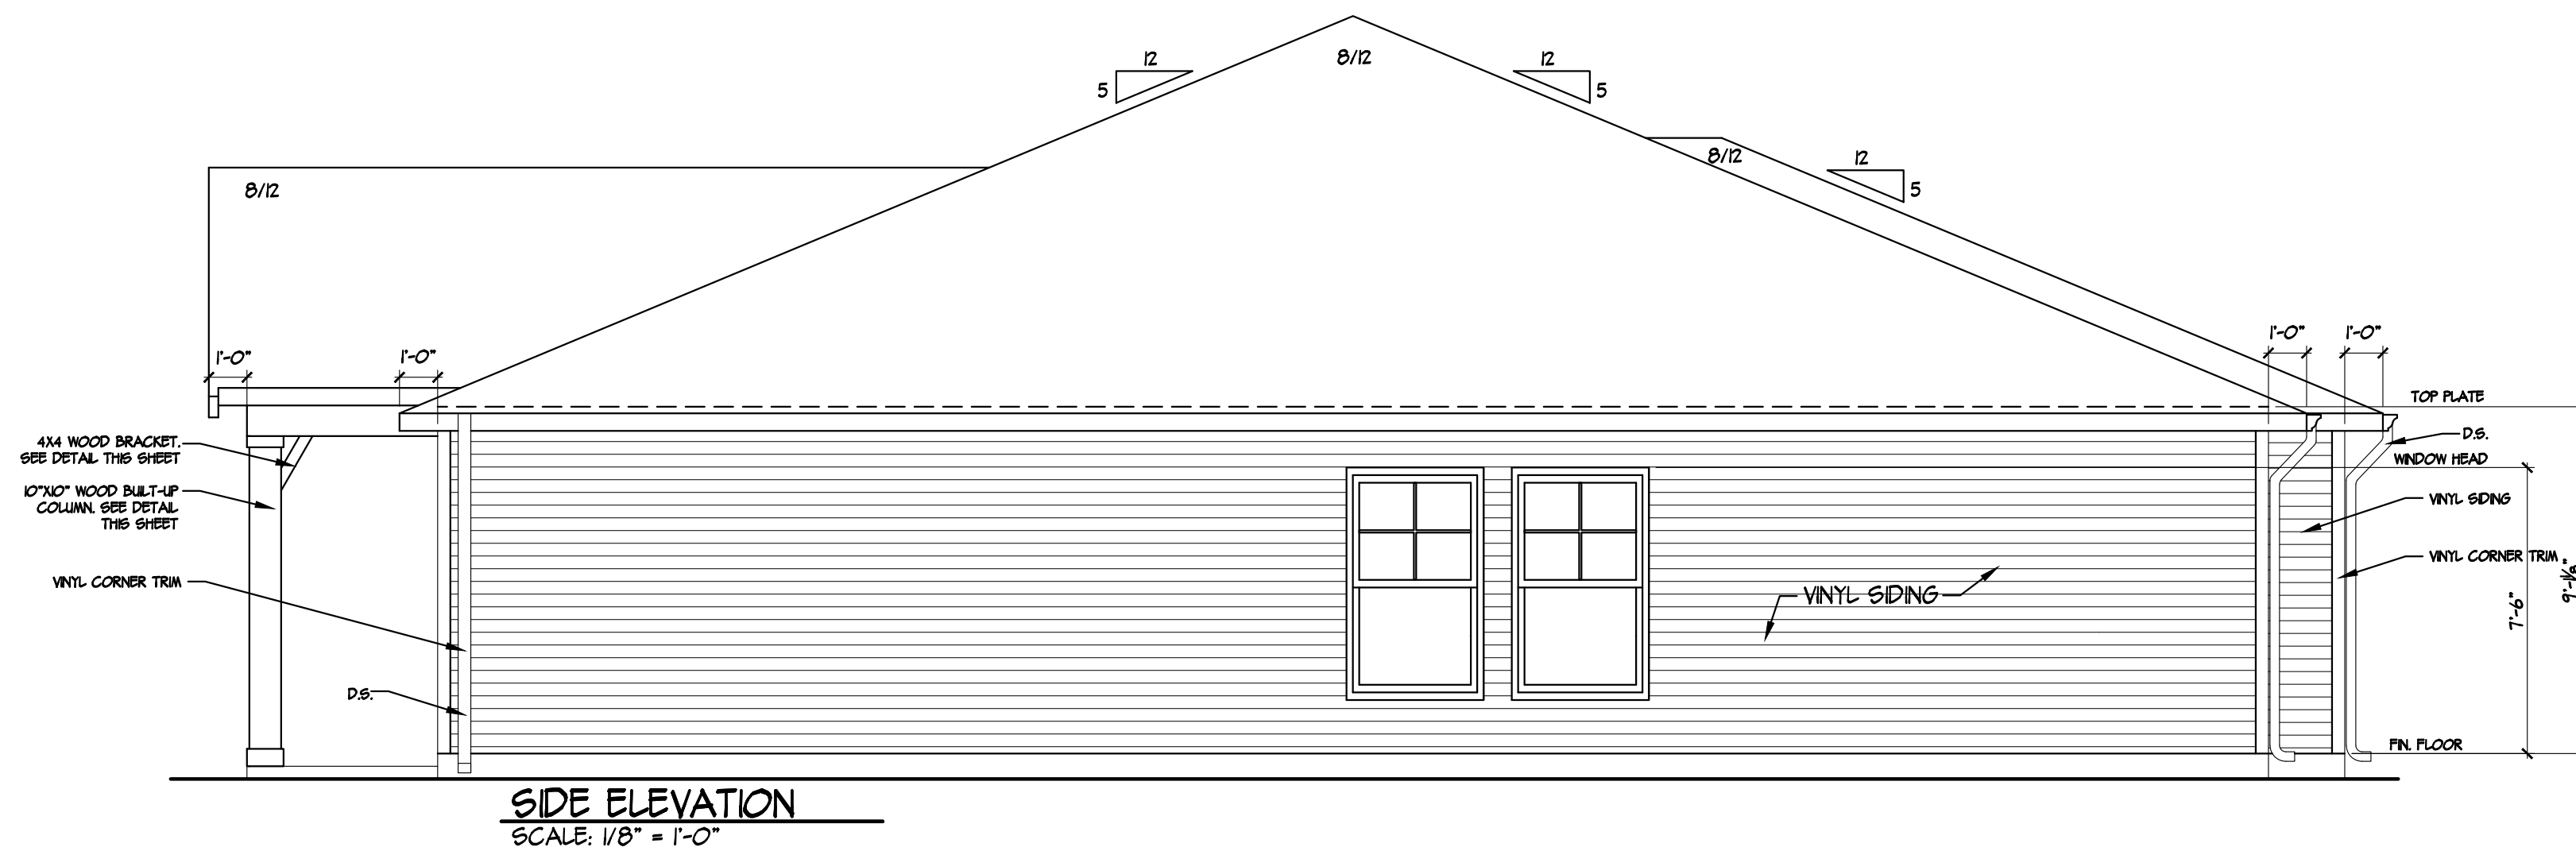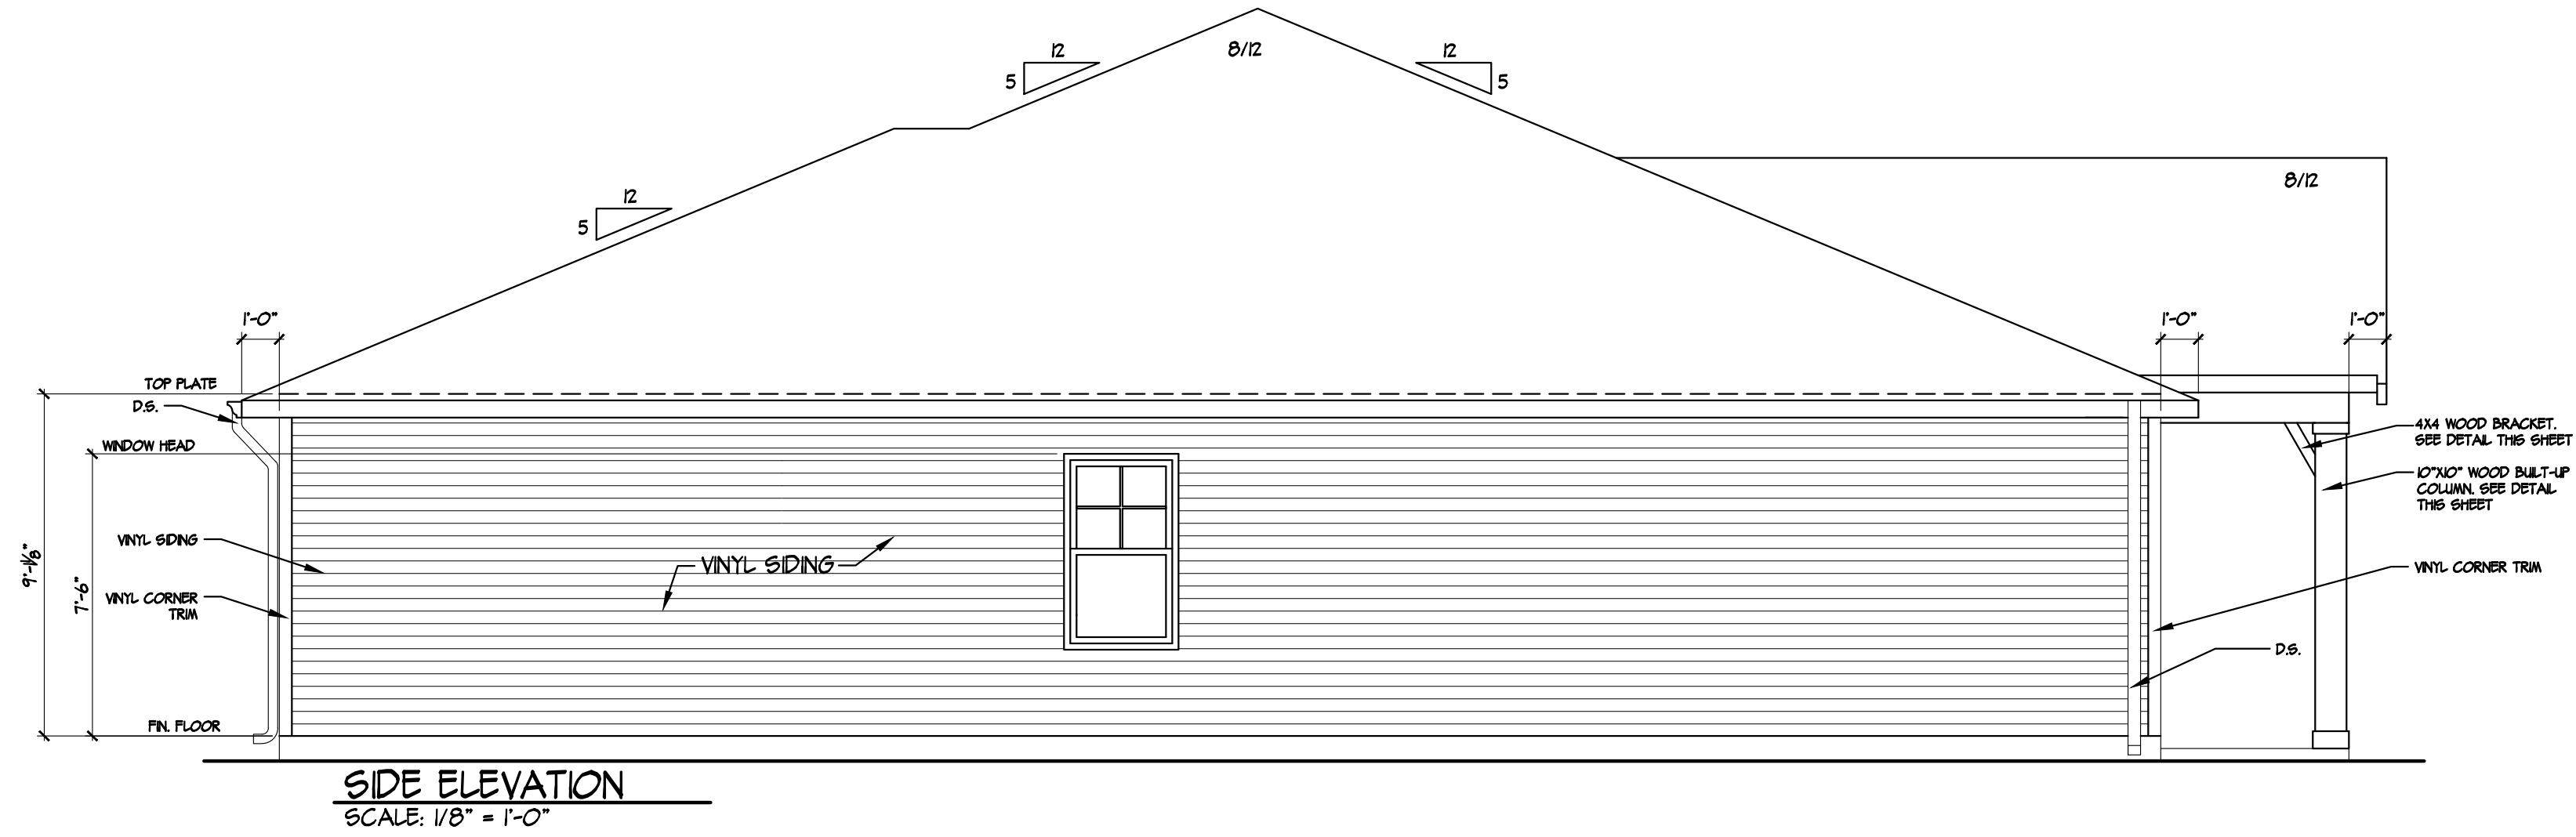

JAGOE
HOMES

3624 WATHENS CROSSING
OWENSBORO, KENTUCKY 42301
(270) 684-0639


DATE: September 16, 2022	
LAST SAVED BY: Fredd.Lucille	
LAST SAVED: Thu, 15 Sep 2022 - 3:08pm	
CREATED: Wed, 29 Aug 2012 - 9:56am	
FILE NAME: 29 WL MKT PLAN 091422.dwg	
TIME PLOTTED: Fri, 16 Sep 2022 - 8:47am	
REVISION:	
PDR#A.B.	DATE:08/15/13
PDR#298	DATE:10/14/13
PDR#730	DATE:7/11/18
PDR#832	DATE:01/07/19
PDR#000	DATE:00/00/00

JAGOE MARKET HOME
9845 MONTE WAY
NEWBURGH, IN 47630
LOT 29 WILLIAMS LANDING
LEONARDO - C
RIGHT & SIDE ELEVATIONS C

Sheet Number
C.6.1.1

© 2001 Jagoe Homes, Inc. Unauthorised use of this plan is in violation of the U.S. Copyright Act, Title 17 of the U.S. Code. Reported square footage is approximate and based upon Architectural Design. Area and actual dimensions may vary according to construction methods. Dimensions used on floor plans are framing dimensions. Municipality requirements regarding size of foundation block may affect framing dimensions shown on plans. Brochures as shown by artist's renditions may not show all standards and options. Specifications may change without notice. Variations may occur by neighborhood, lot location, and home series. Not all plan brochures may be placed on every lot. Location of residence on lot shall be determined by Jagoe Homes Inc.

GENERAL NOTES :
 NOTE :
 FIXTURE LOCATIONS MAY BE ADJUSTED ON SITE DUE TO STRUCTURAL OR MECHANICAL LOCATIONS.
 STRUCTURED WIRING PANEL TO INCLUDE THE FOLLOWING :
 (1) LEGRAND EFN3050 PLASTIC ENCLOSED PANEL W/ HINGED DOOR, OR EQUIV.
 (1) DEDICATED 110V OUTLET
 (1) COAX FROM PANEL TO EXTERIOR SERVICE
 (1) 1" CONDUIT W/ FULL STRING TO EXTERIOR SERVICE
 ALL SHIELDED CAT6 TO BE HOMERUN TO SERVICE PANEL WITH MALE TERMINATION AT PANEL AND FEMALE TERMINATION WALL PLATE AT DESIGNATED LOCATIONS THROUGHOUT THE HOUSE
 SEE SHEET C.2.1.1 FOR TURNED OUTLETS AT KITCHEN BACKSPLASH

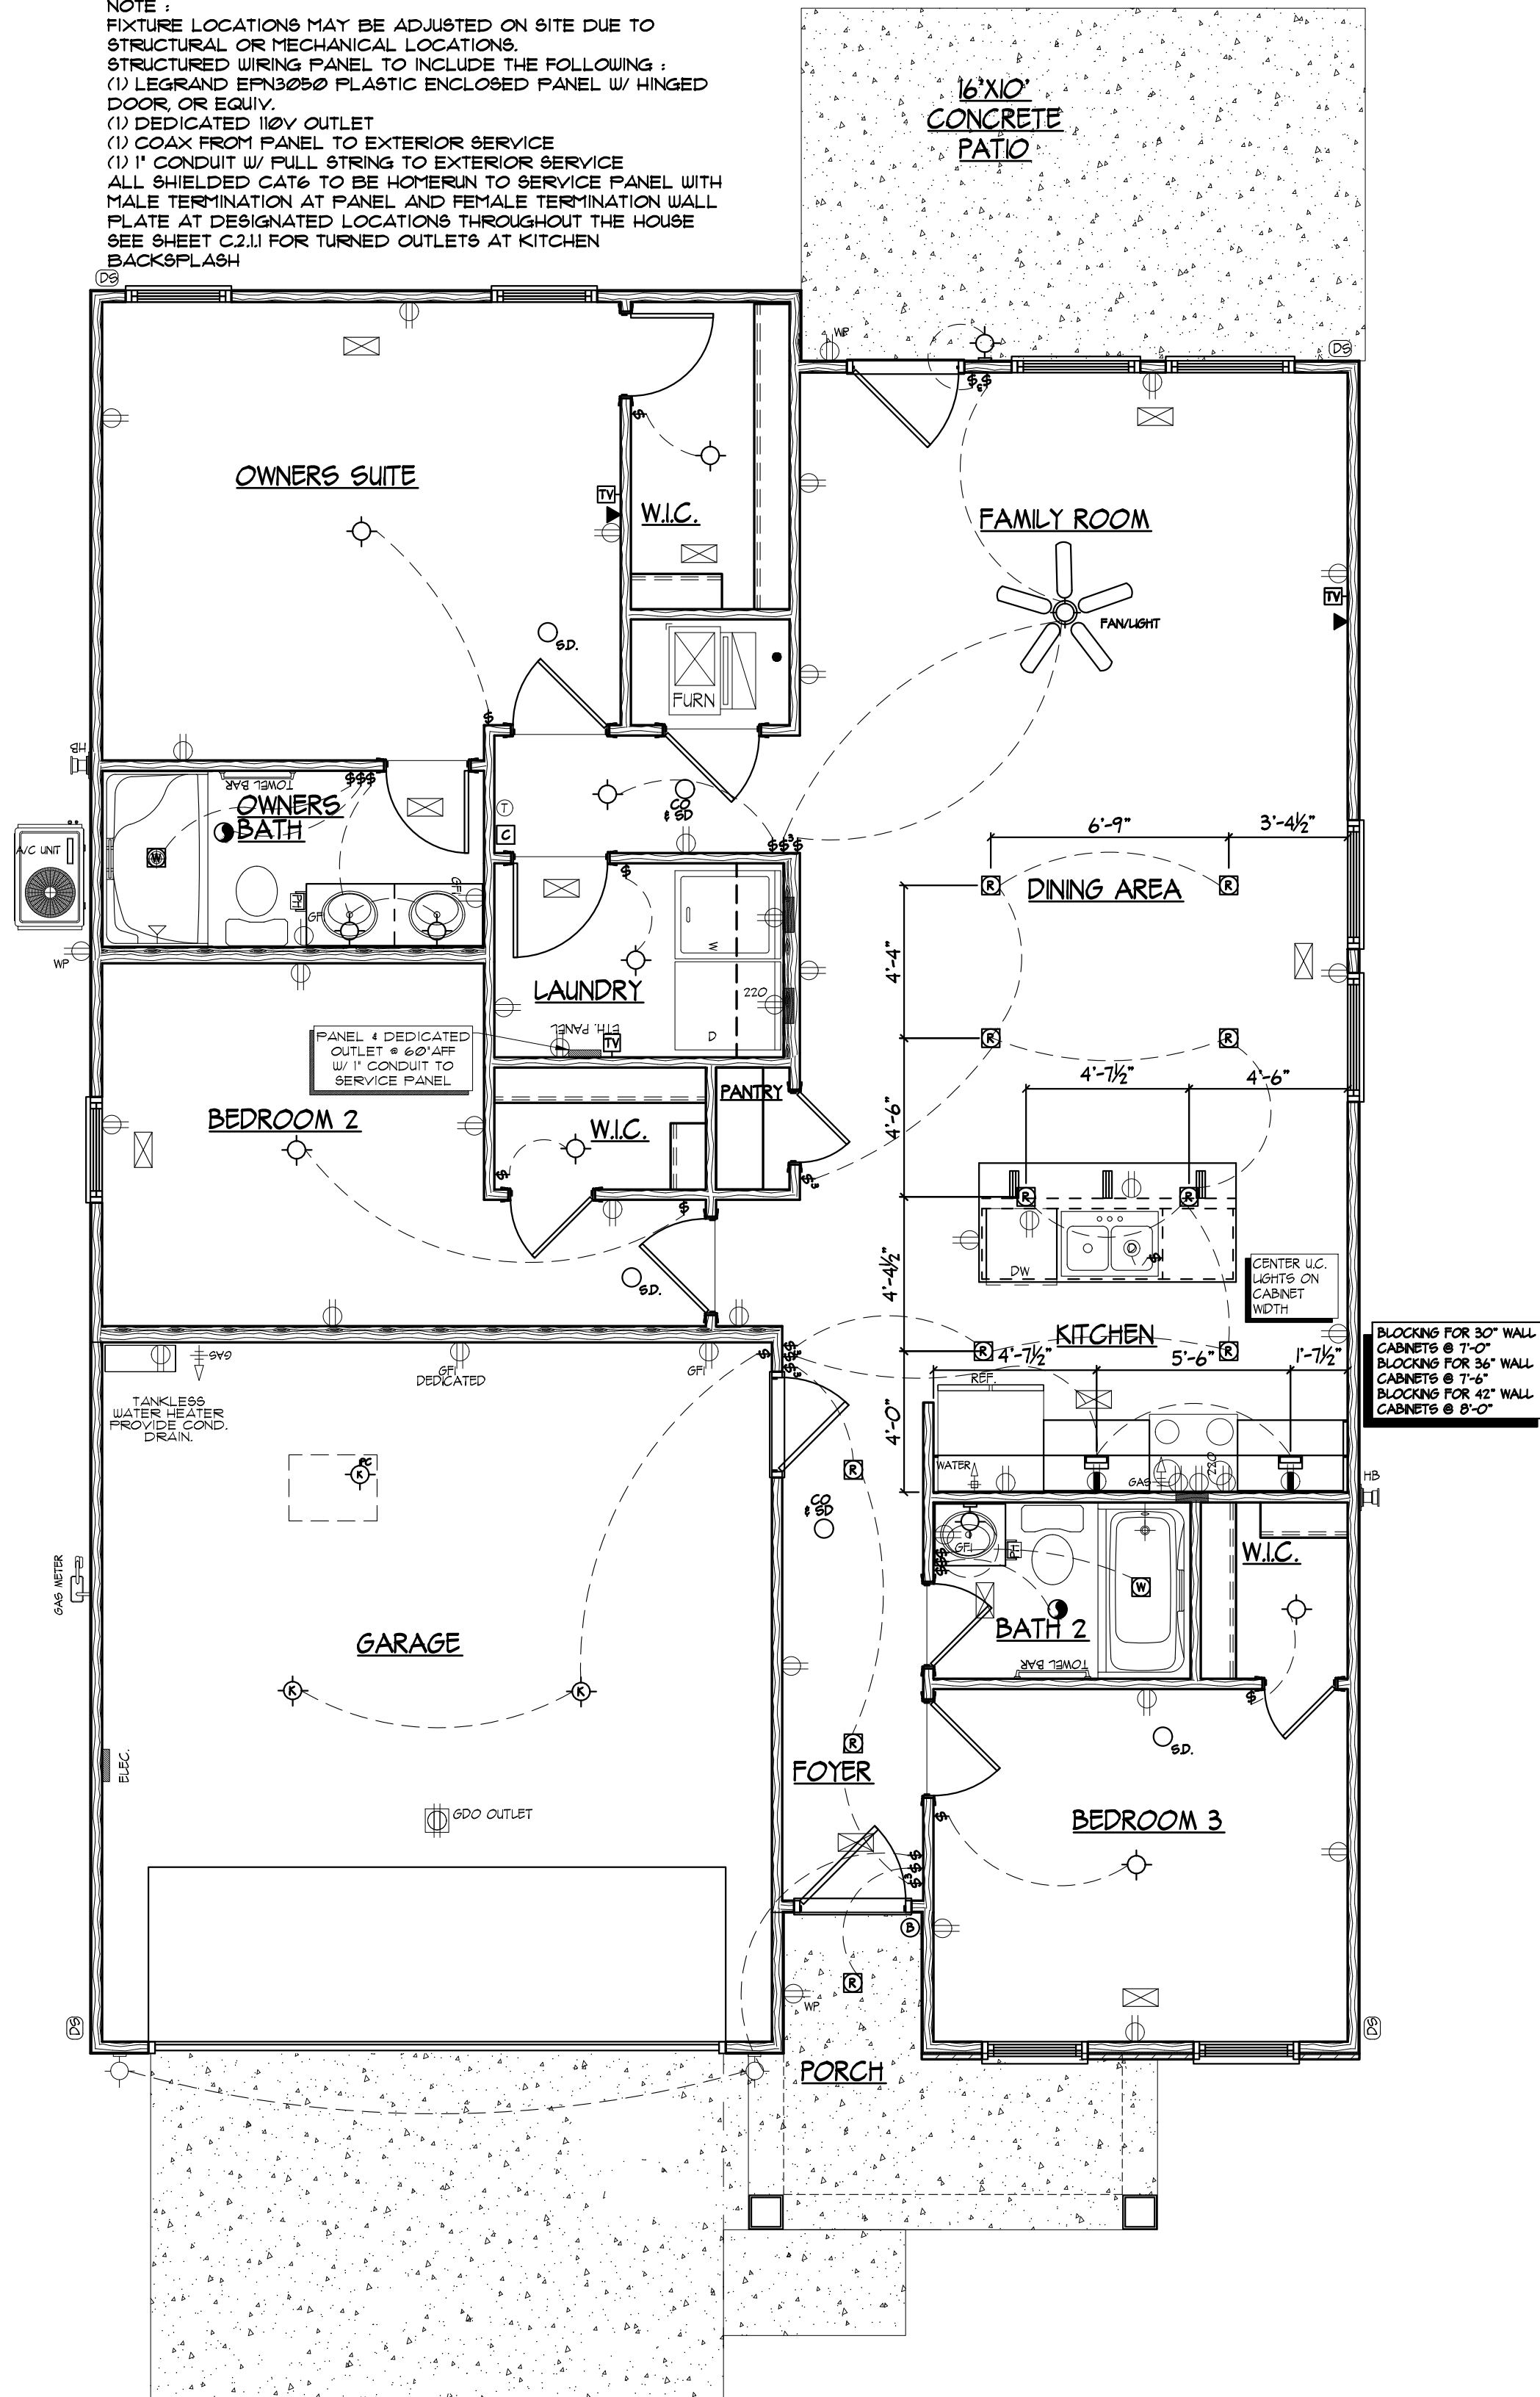

ELECTRICAL LEGEND	
SYMBOL	DESCRIPTION
	WIRE SWITCHING & CONNECTIONS
	DUPLEX OUTLET (GROUNDED TYPE)
	DOUBLE DUPLEX OUTLET (QUAD) (GROUNDED TYPE)
	GROUND FAULT INTERRUPTER DUPLEX OUTLET
	WEATHER PROOF DUPLEX OUTLET
	WALL SWITCH CONTROLLED DUPLEX OUTLET
	ABOVE COUNTER LOCATION
	FLUSH FLOOR DUPLEX OUTLET (OWNER VERIFY)
	220 VOLT OUTLET OR CONNECTION
	CEILING MOUNTED OUTLET FOR GARAGE DOOR
	SINGLE POLE WALL SWITCH
	3-WAY WALL SWITCH
	SINGLE POLE WALL SWITCH WITH DIMMER
	3-WAY WALL SWITCH WITH DIMMER
	OVER / UNDER SWITCH
	CEILING MOUNTED LIGHT FIXTURE
	CEILING MOUNTED KEYLESS LIGHT FIXTURE
	CEILING MOUNT KEYLESS LIGHT W/ PULL CHAIN
	WALL BRACKET MOUNTED LIGHT FIXTURE
	HANGING CEILING MOUNTED LIGHT FIXTURE
	RECESSED DIRECTIONAL CEILING LIGHT FIXTURE (EYEBALL)
	RECESSED CEILING LIGHT FIXTURE
	RECESSED LIGHT FOR WET AREA
	CEILING MOUNTED FAN - EXHAUST
	CEILING MOUNTED FAN AND LIGHT
	BAR LIGHTS (SIZES MAY VARY)
	UNDER CABINET LIGHTING
	STAIRWAY STEP LIGHTS
	EXTERIOR CAST ALUMINUM FLOOD LIGHTS
	'SATCO' 7" LED LIGHT
	'SATCO' 9" LED LIGHT
	2 BULB 2'-0" FLUORESCENT LIGHT
	2 BULB 4'-0" FLUORESCENT LIGHT
	4 BULB 4'-0" FLUORESCENT LIGHT
	TELEPHONE OUTLET
	TELEVISION ANTENNA / CABLE OUTLET
	CAT 6 OUTLET
	120 VOLT ELECTRICAL PANEL
	DOOR BELL BUTTON
	DOOR CHIME LOCATION
	THERMOSTAT LOCATION
	SINK GARBAGE DISPOSAL
	SMOKE DETECTOR
	COMBINATION CARBON MONOXIDE & SMOKE DETECTOR
	FAN/LIGHT
	FAN ONLY




3624 WATHENS CROSSING
 OWENSBORO, KENTUCKY 42301
 (270) 684-0639

DATE:	September 16, 2022
LAST SAVED BY:	Fredd.Lucille
LAST SAVED:	Thu, 15 Sep 2022 - 3:08pm
CREATED:	Wed, 29 Aug 2012 - 9:56am
FILE NAME:	29 WL MKT PLAN 091422.dwg
TIME PLOTTED:	Fri, 16 Sep 2022 - 8:47am
REVISION:	
PDR#A.B.	DATE:08/15/13
PDR#298	DATE:10/14/13
PDR#730	DATE:7/11/18
PDR#832	DATE:01/07/19
PDR#000	DATE:00/00/00

JAGOE MARKET HOME
 9845 MONTE WAY
 NEWBURGH, IN 47630
 LOT 29 WILLIAMS LANDING
 LEONARDO - C
 MAIN FLOOR ELECTRICAL C ELEV.

Sheet Number
C.7.1.1

© 2001 Jagoe Homes, Inc. Unauthorized use of this plan is in violation of the U.S. Copyright Act, Title 17 of the U.S. Code. Reported square footage is approximate and based upon Architectural Design. Area and actual dimensions may vary according to construction methods. Dimensions used on floor plans are framing dimensions. Municipality requirements regarding size of foundation block may affect framing dimensions shown on plans. Brochures as shown by artist's renditions may not show all standards and options. Specifications may change without notice. Variations may occur by neighborhood, lot location, and home series. Not all plan brochures may be placed on every lot. Location of residence on lot shall be determined by Jagoe Homes Inc.

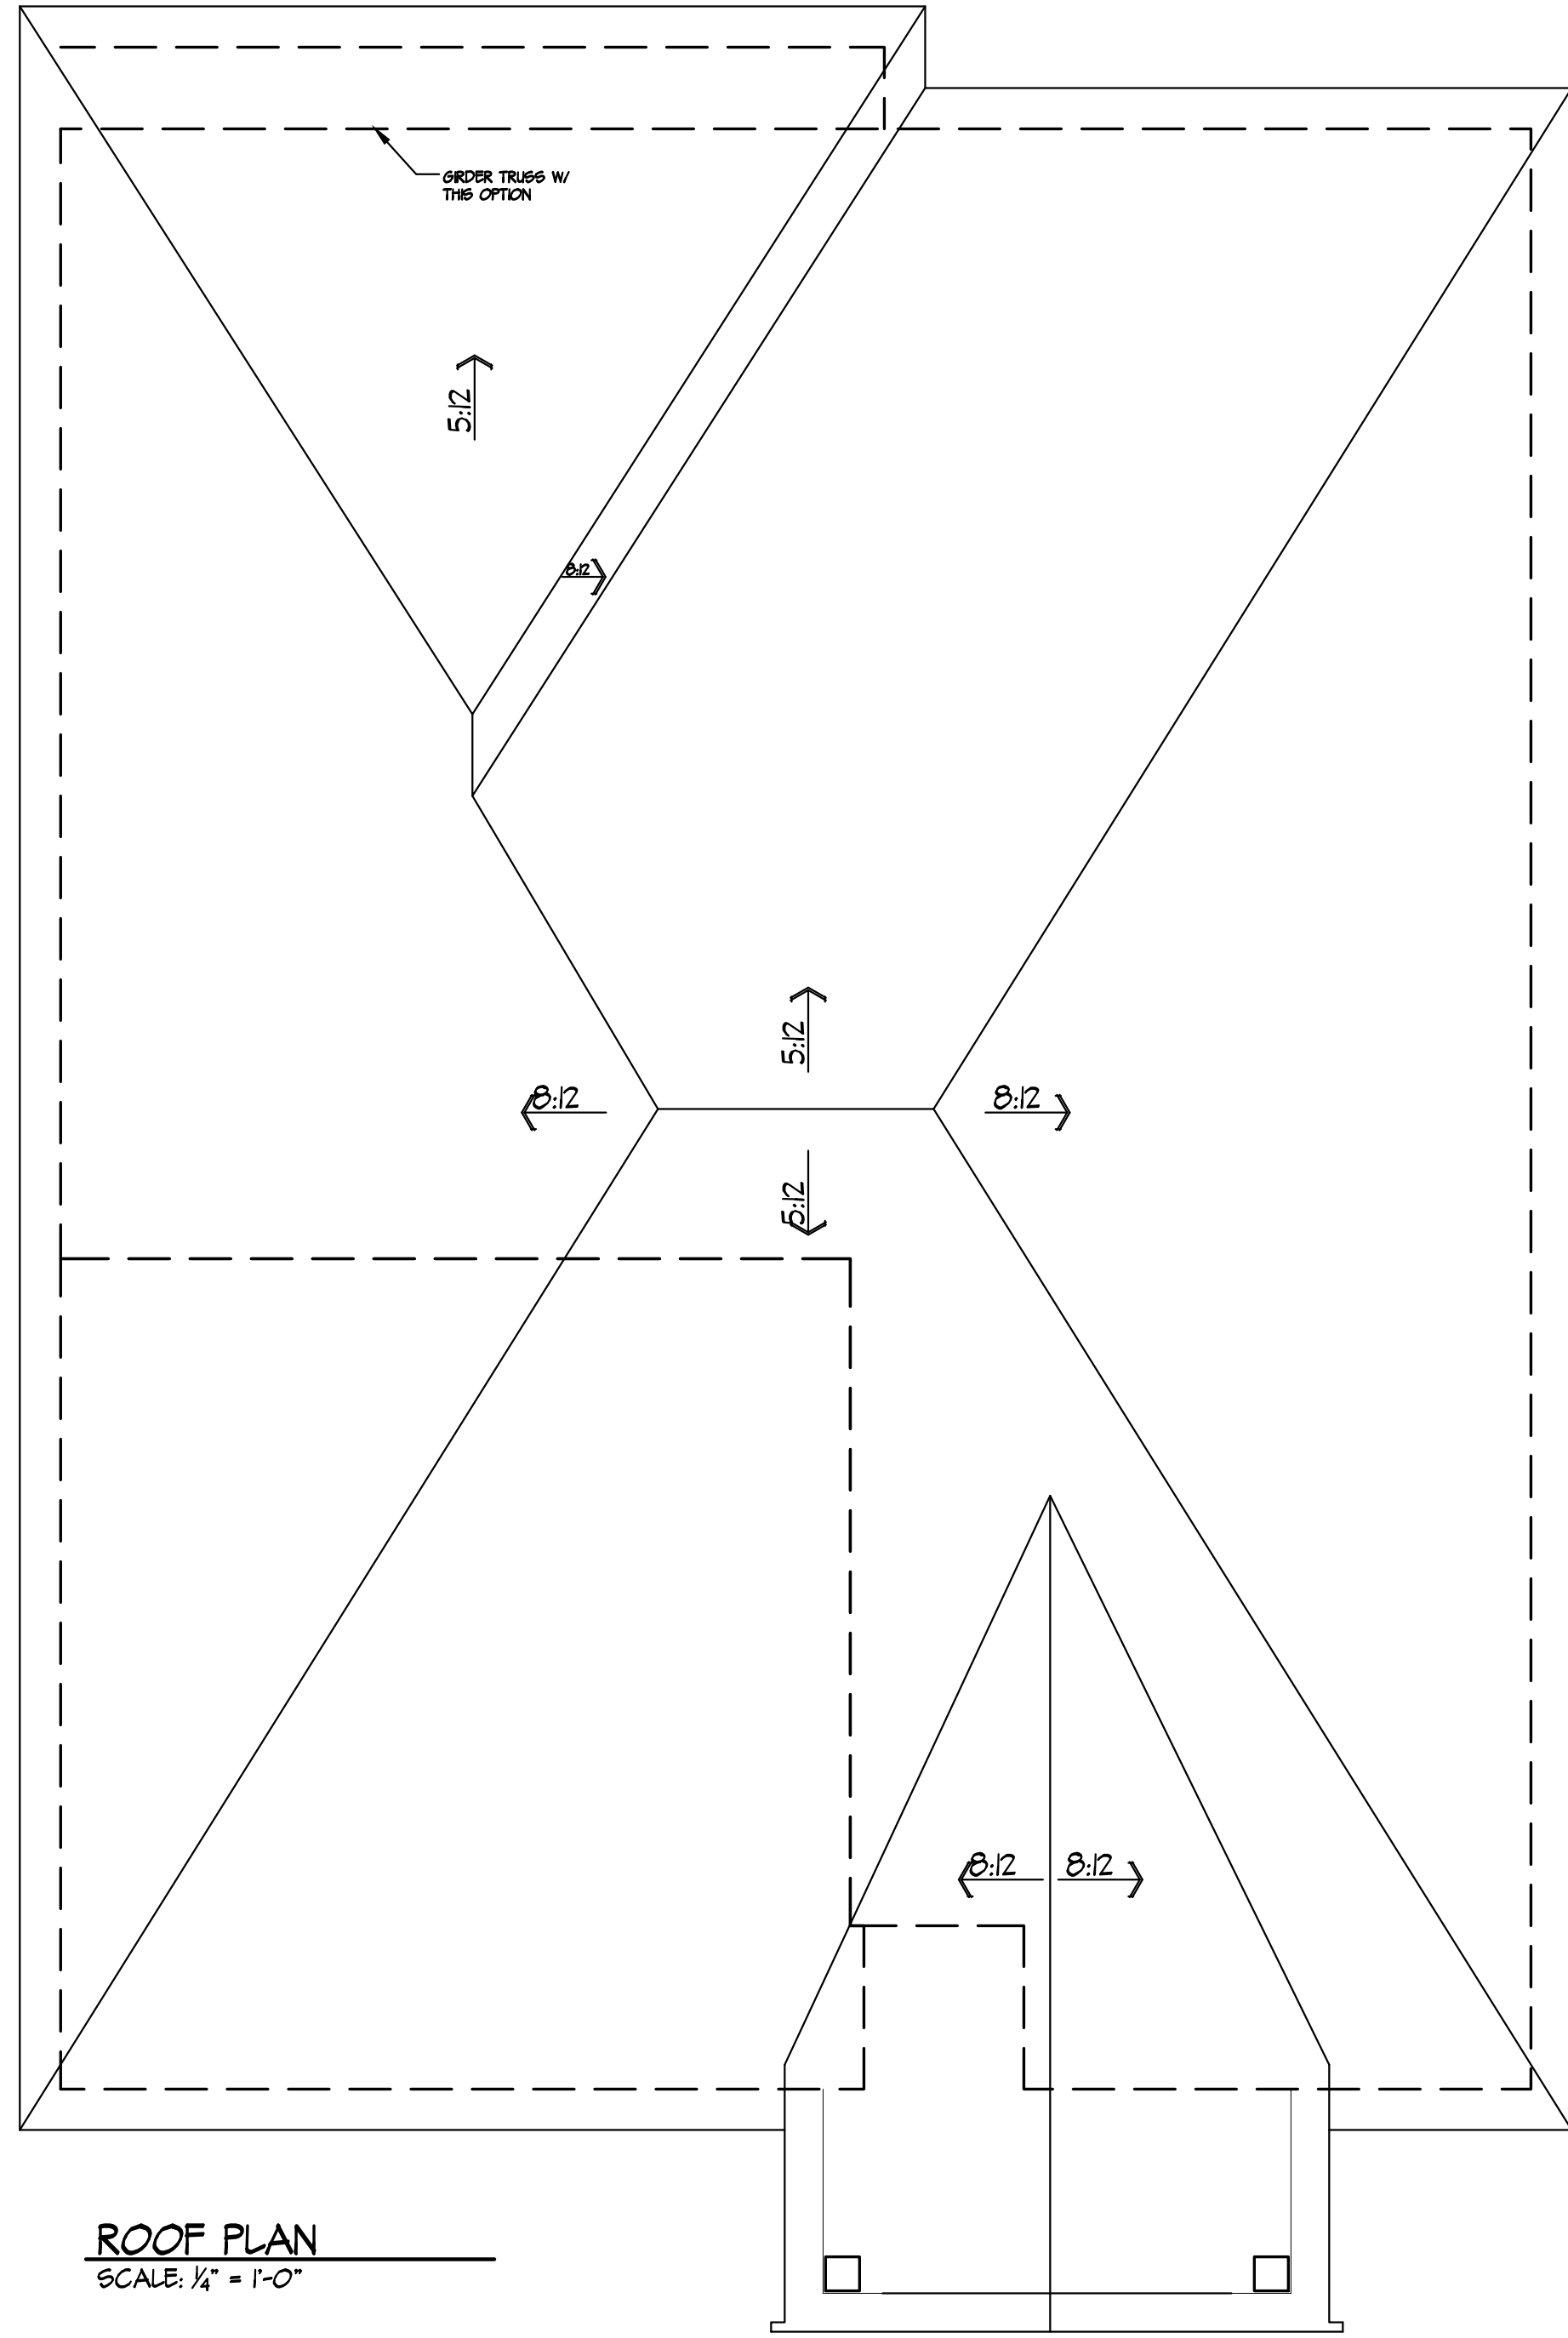

ROOF PLAN
SCALE: 1/4" = 1'-0"



3624 WATHENS CROSSING
OWENSBORO, KENTUCKY 42301
(270) 684-0639

DATE: September 16, 2022
LAST SAVED BY: Fredd.Lucille
LAST SAVED: Thu, 15 Sep 2022 - 3:08pm
CREATED: Wed, 29 Aug 2012 - 9:56am
FILE NAME: 29 WL MKT PLAN 091422.dwg
TIME PLOTTED: Fri, 16 Sep 2022 - 8:47am
REVISION: PDR#A.B. DATE:08/15/13 PDR#298 DATE:10/14/13 PDR#730 DATE:7/11/18 PDR#832 DATE:01/07/19 PDR#000 DATE:00/00/00

JAGOE MARKET HOME
9845 MONTE WAY
NEWBURGH, IN 47630
LOT 29 WILLIAMS LANDING
LEONARDO - C
ROOF PLAN C.ELEV.

Sheet Number
C.9.1.1